


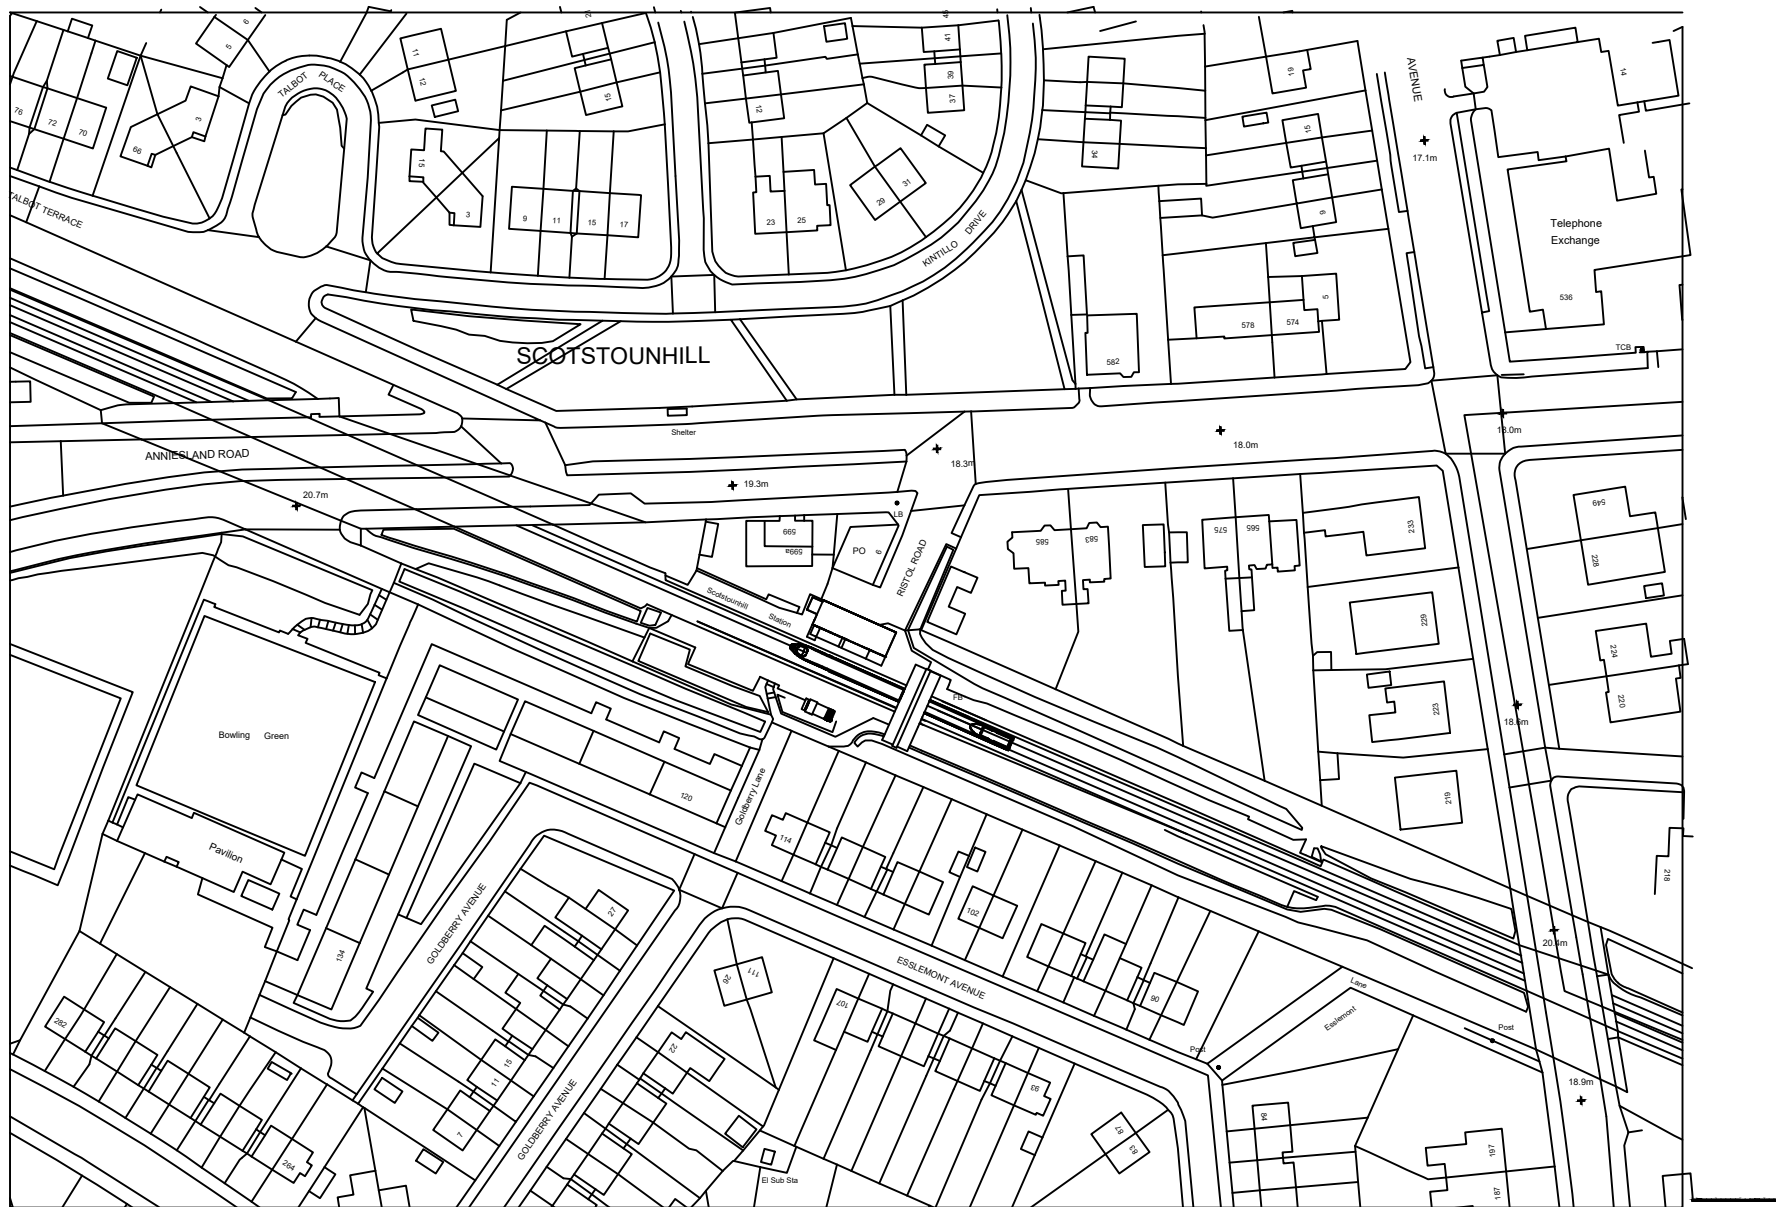

Project Name:

Scotstounhill Railway Station


Drawing Name:

Proposed Location Plan

Scale 1/1250 (non scale @A4)

Sheet Number: 1/16

Date: 05.04.2021

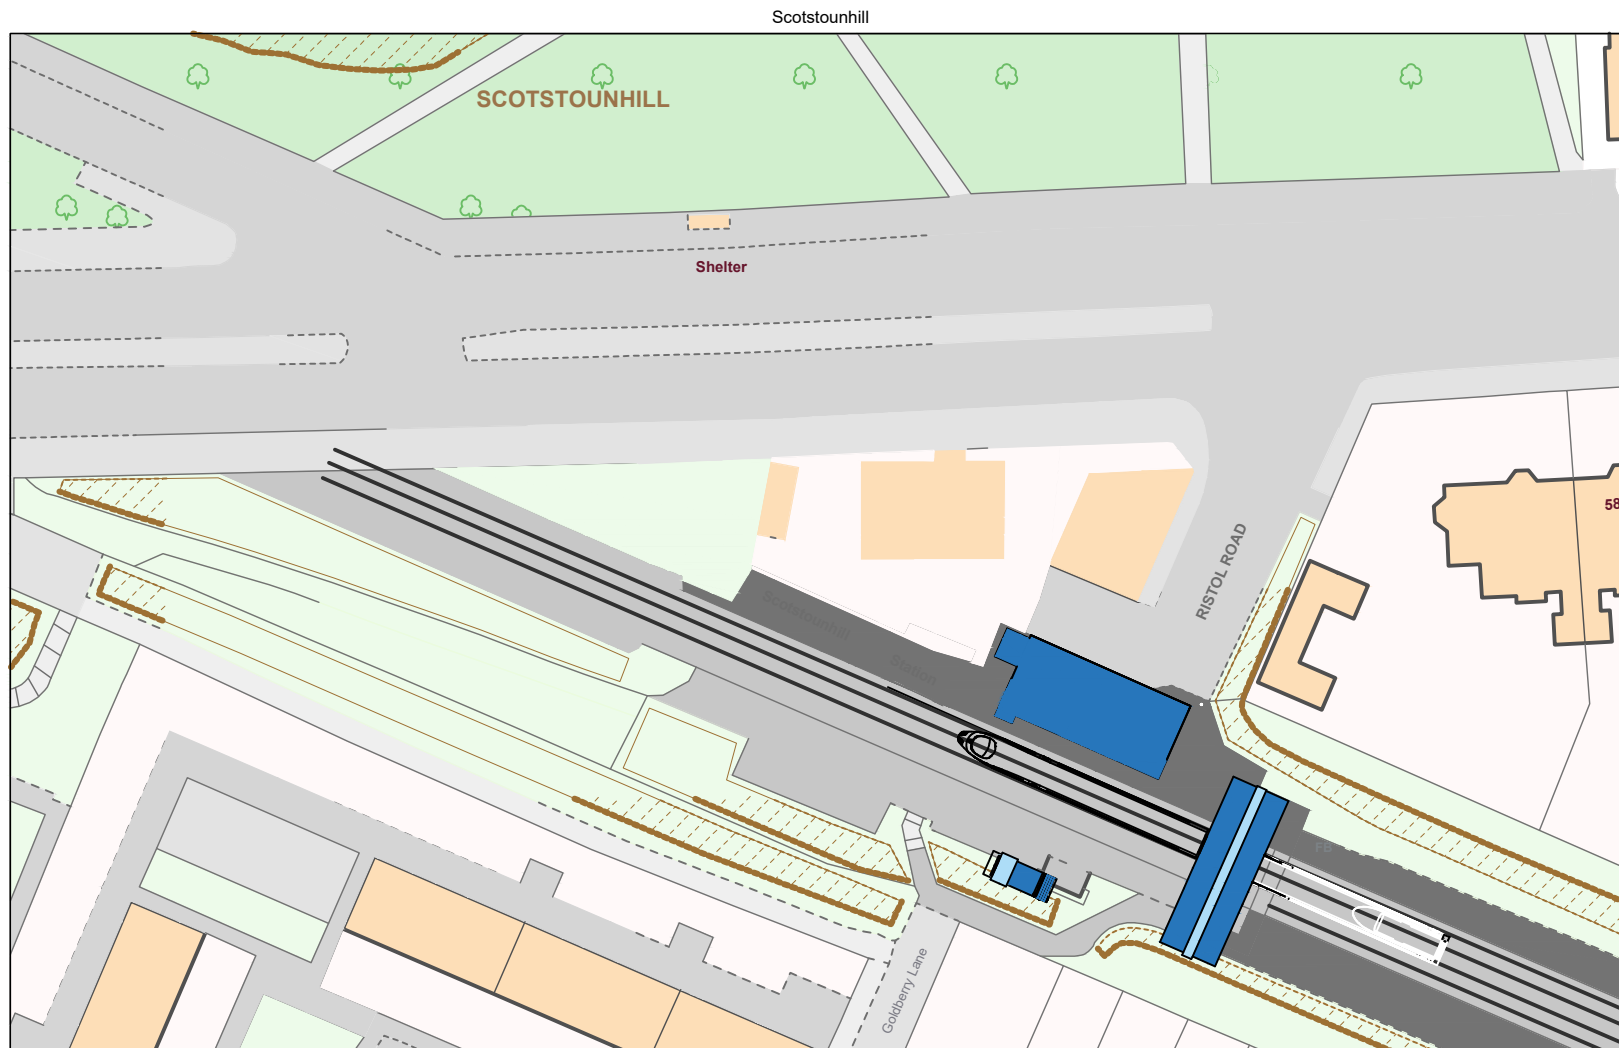

Project Name:

Scotstounhill Railway Station



Drawing Name:

Proposed Site

Scale 1:500 (non scale @A4)

Sheet Number: 2/16

 Date: 05.04.2021

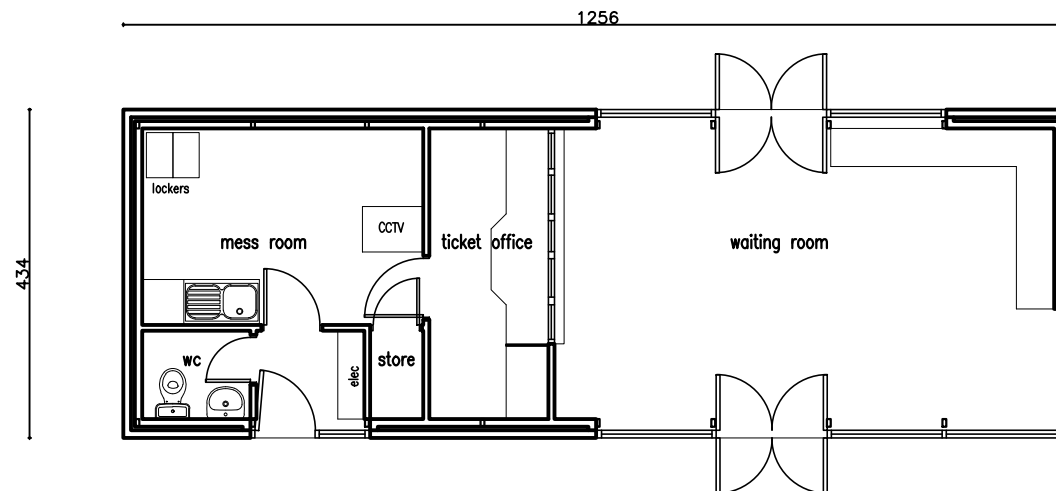

Project Name:

Scotstounhill Railway Station


Drawing Name:

Existing Floor Plan


Scale 1:100 @A4

Sheet Number: 3/16


Date: 05.04.2021

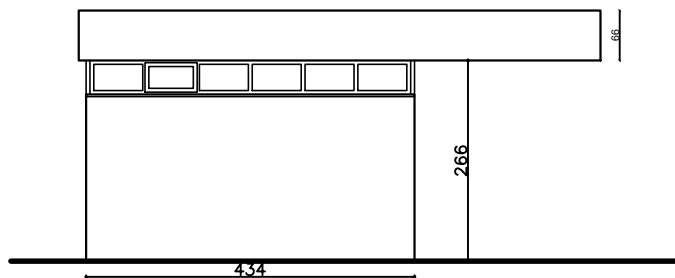


west elevation

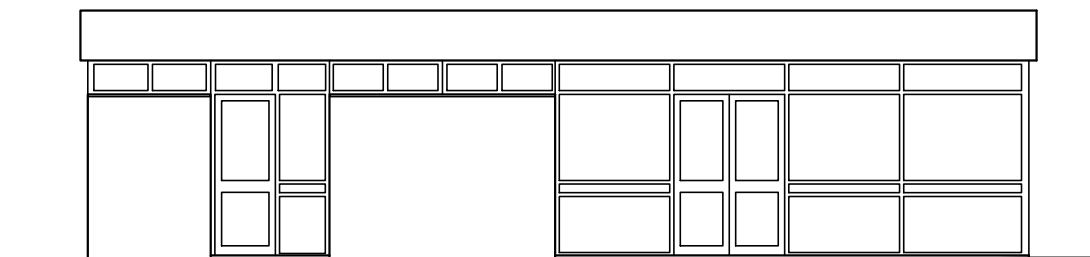


south elevation

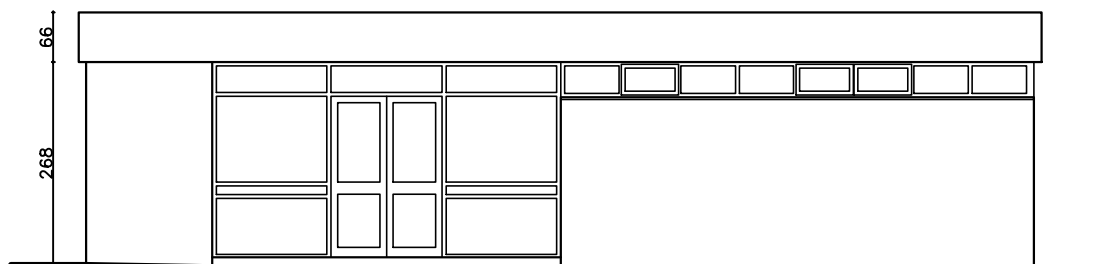

north elevation

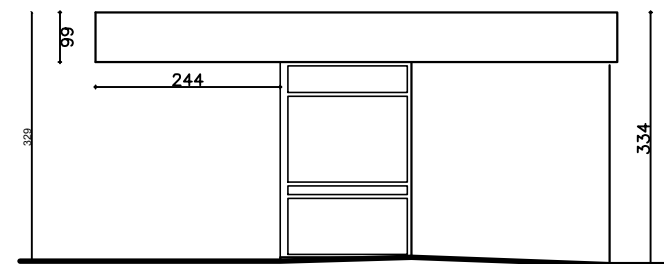

east elevation

 

Project Name:

Scotstounhill Railway Station


Drawing Name:

Existing Elevations

Scale 1:100 @A4

Sheet Number: 4/16

Date: 05.04.2021

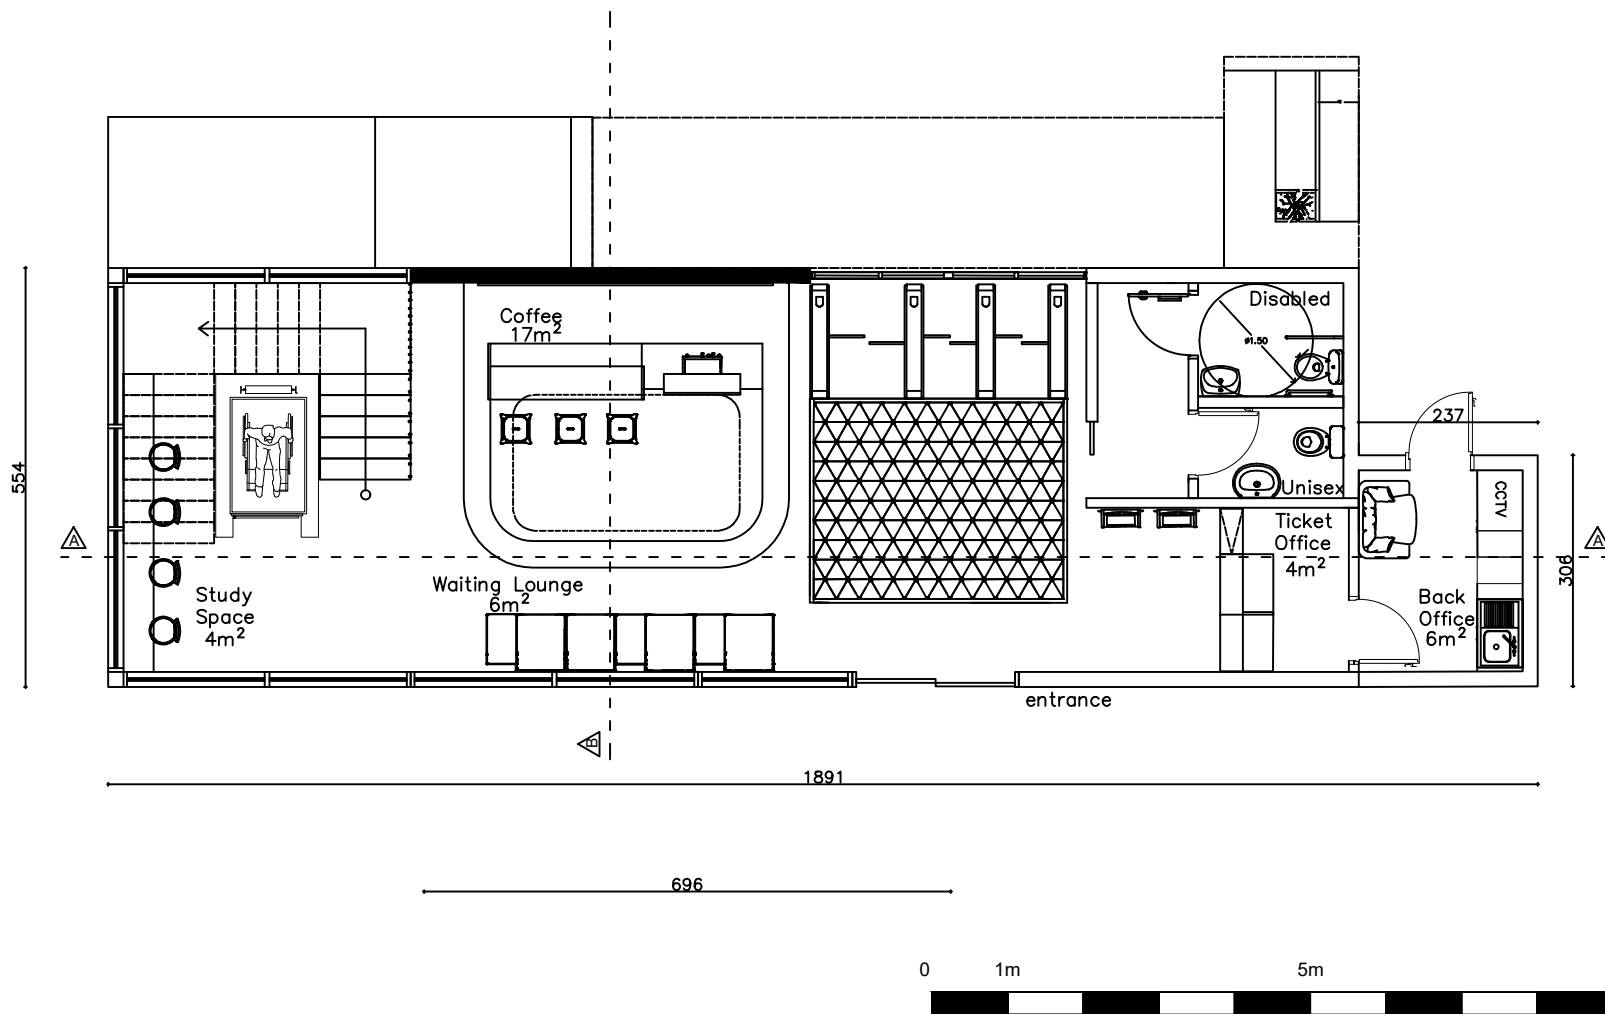

Project Name:

Scotstounhill Railway Station


Drawing Name:

Ground Floor Plan

Scale 1:100 @A4

Sheet Number: 5/16

Date: 05.04.2021

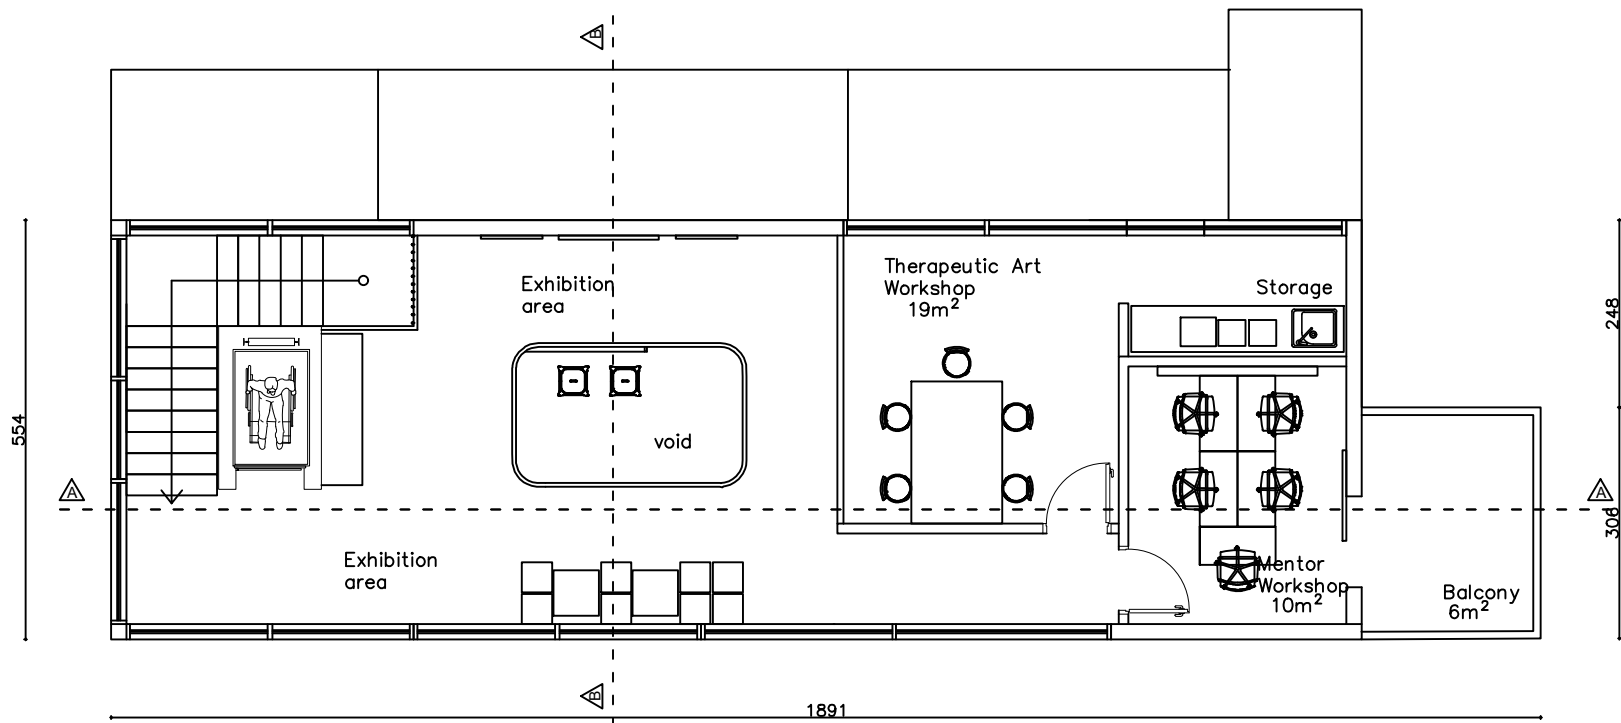

Project Name:

Scotstounhill Railway Station


Drawing Name:

First Floor Plan

Scale 1:100 @A4

Sheet Number: 6/16

Date: 05.04.2021

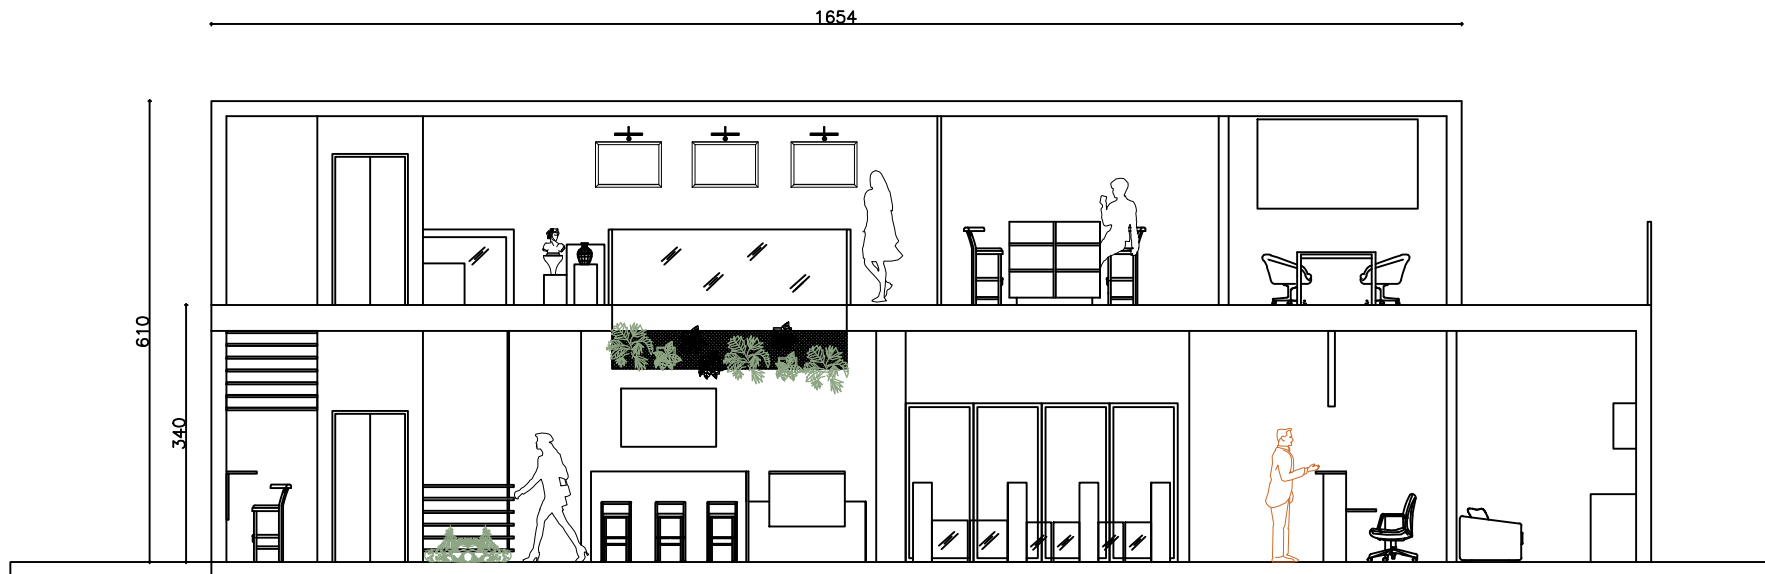

Project Name:

Scotstounhill Railway Station



Drawing Name:

Section AA

Scale 1:100 @A4

Sheet Number: 7/16

 Date: 05.04.2021

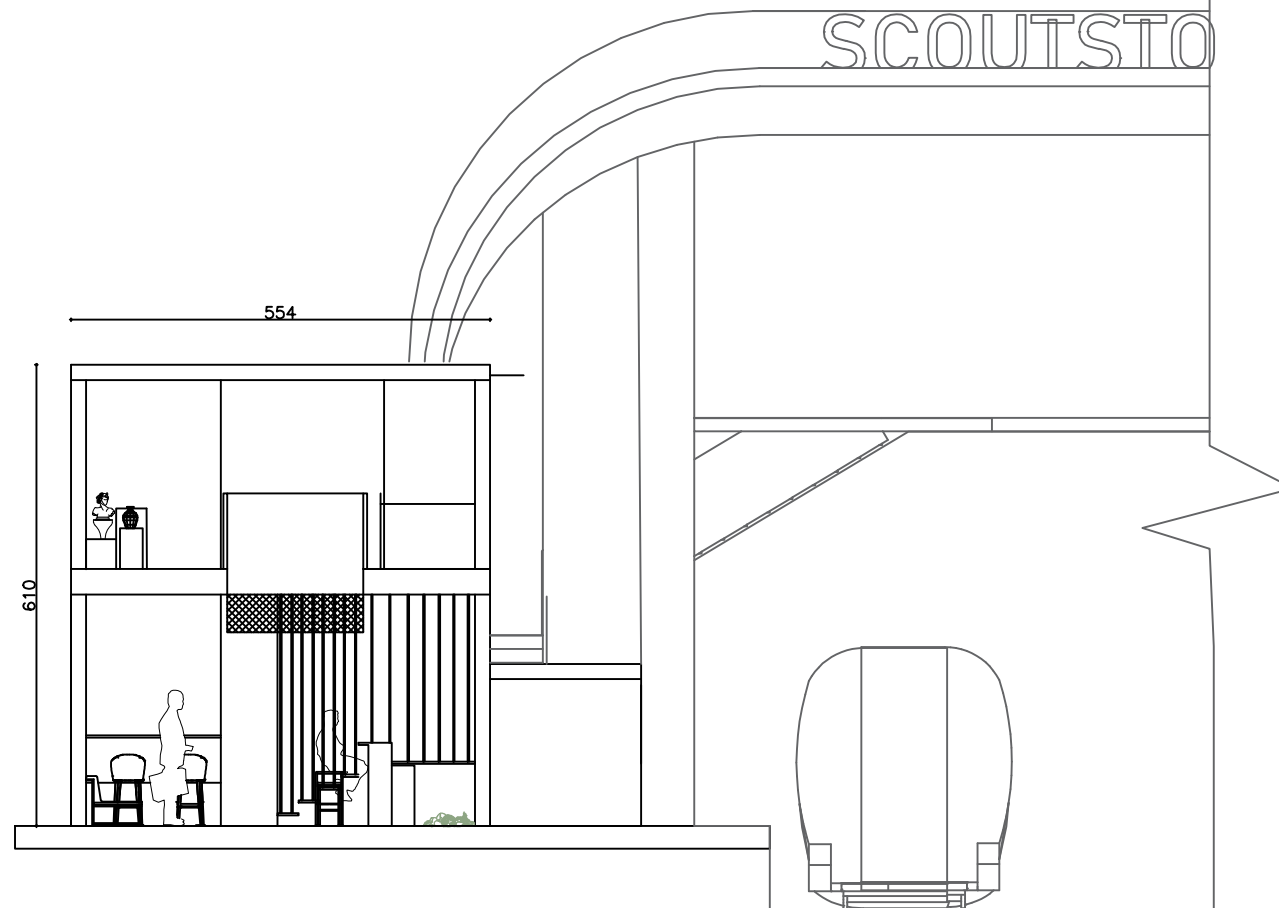

Project Name:

Scotstounhill Railway Station


Drawing Name:

Section BB

Scale 1:100 @A4

Sheet Number: 8/16

Date: 05.04.2021

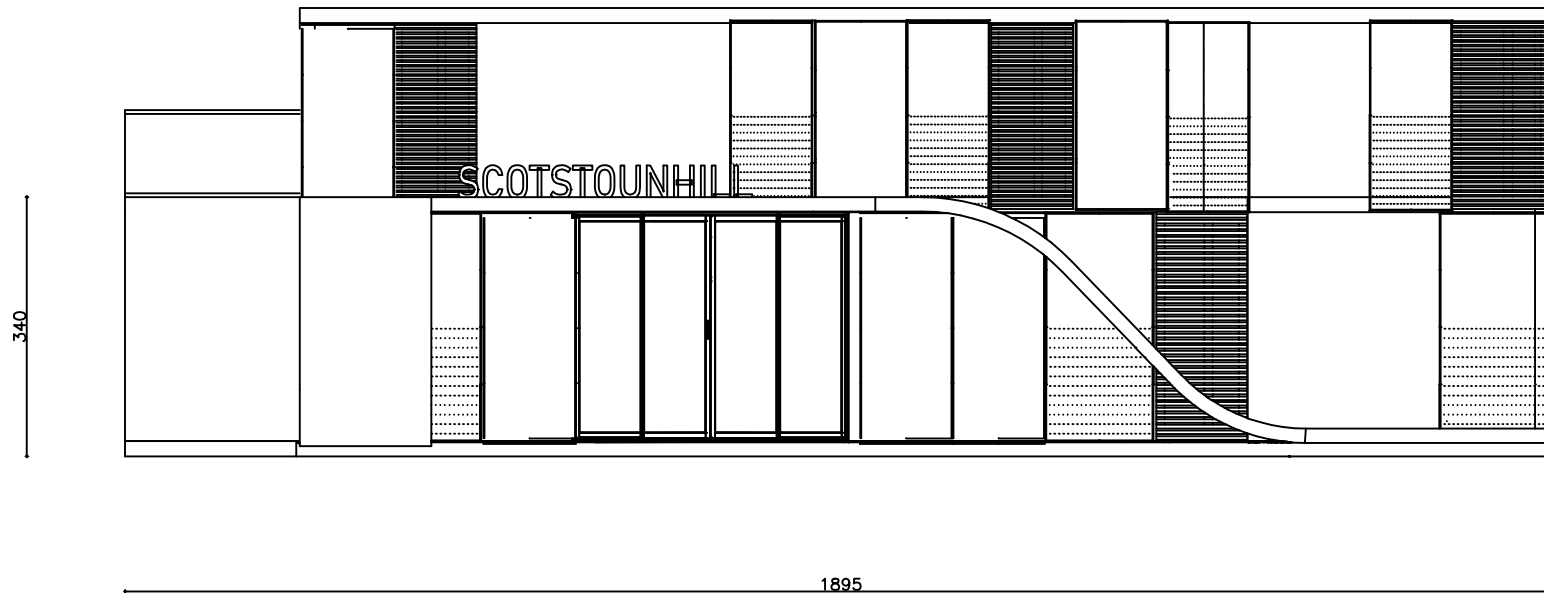

Project Name:

Scotstounhill Railway Station


Drawing Name:

Elevation

Scale 1:100 @A4

Sheet Number: 9/16

Date: 05.04.2021

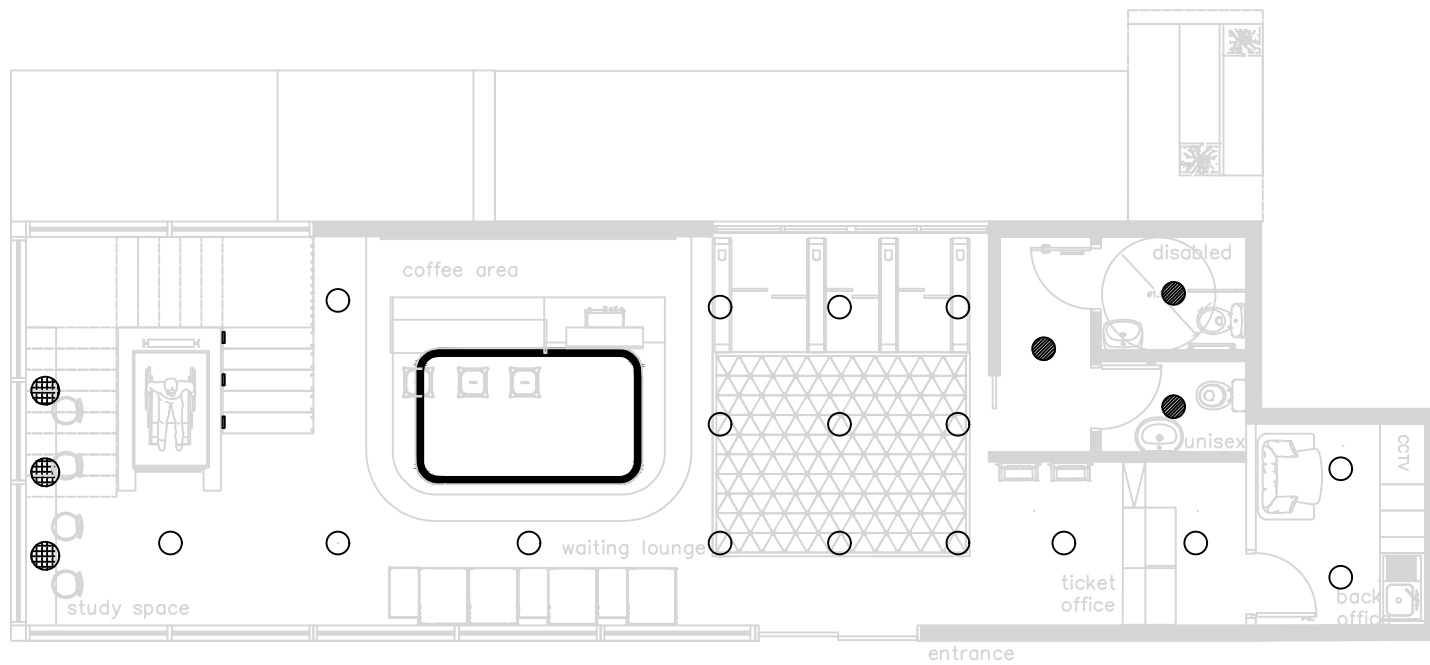

LEGEND

- Surface Mounted Led Light (sensor)
- Surface Mounted Led Light (30cm)
- ▮ Stair Step Light
- Study Area Suspended Light



Project Name:

Scotstounhill Railway Station


Drawing Name:

Lighting Layout Ground F.

Scale 1:100 @A4

Sheet Number: 10/16

Date: 05.04.2021

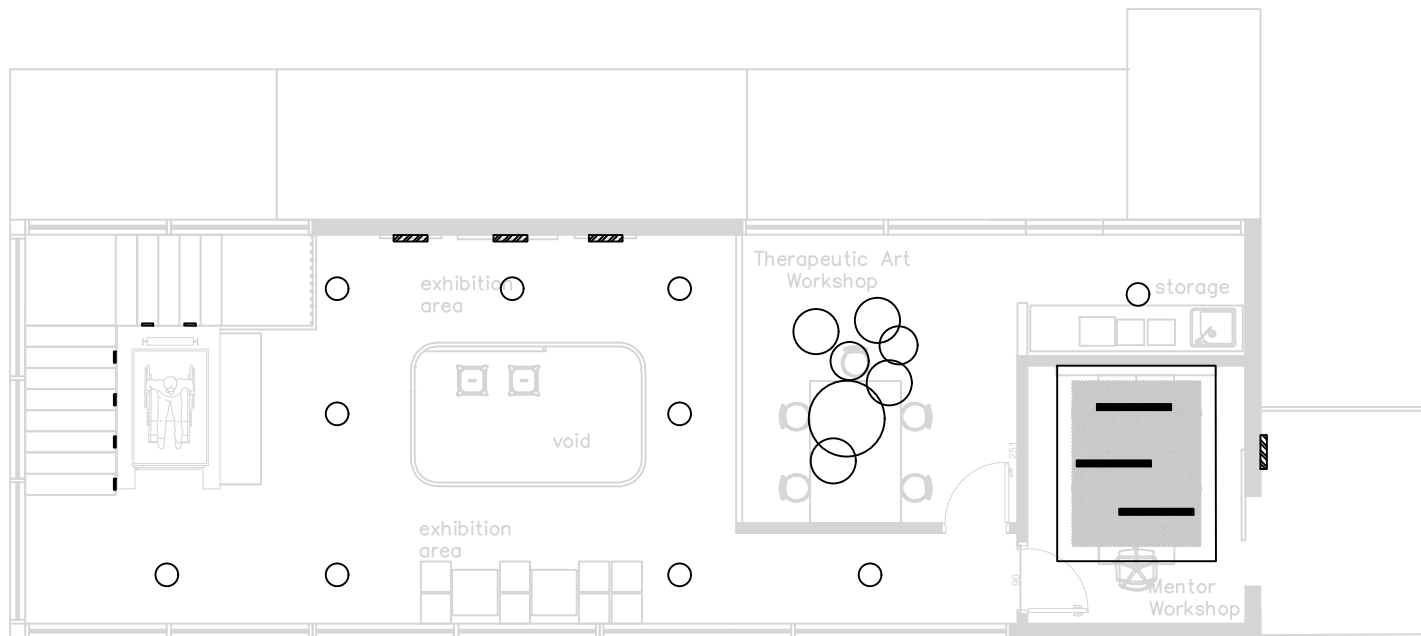

LEGEND	
	Surface Mounted Led Light (30cm)
	Wall Light for frames
	Led Light(8*98cm)
	Stair Step Light
	Suspended Various Dimension Lights



Project Name:

Scotstounhill Railway Station

Drawing Name:




Lighting Layout First F.

Scale 1:100 @A4



Sheet Number: 11/16

Date: 05.04.2021

Ticket& Info Office Desk

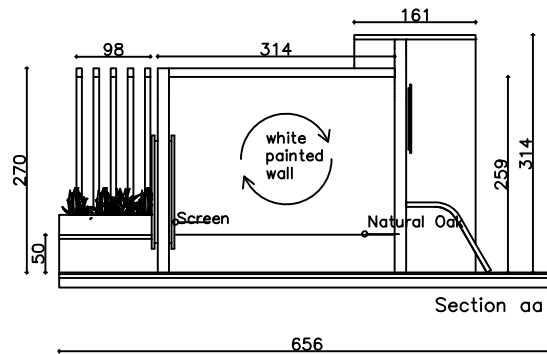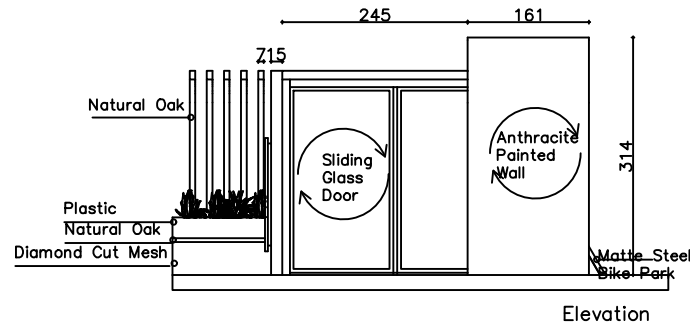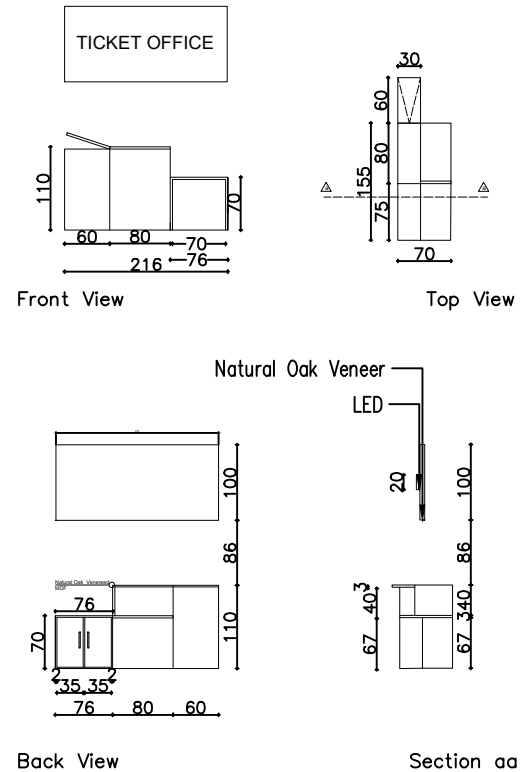

Platform 2 Waiting Area

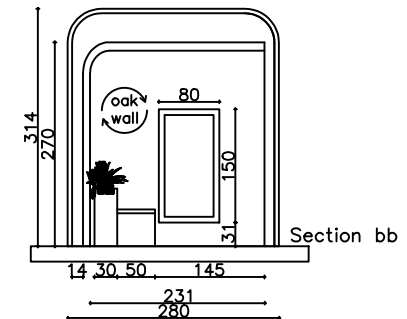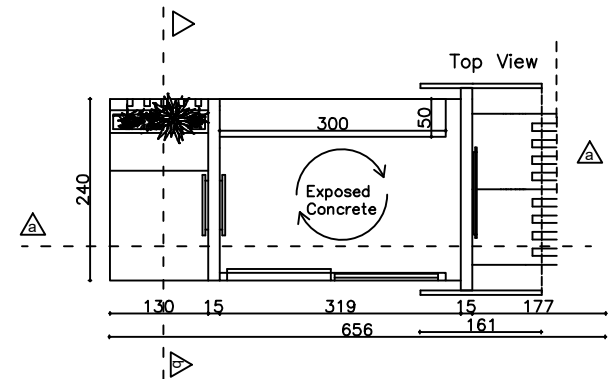

Project Name:

Scotstounhill Railway Station


Drawing Name:

Detail Drawings

Scale 1:20 @B0

Sheet Number: 12/16

Date: 05.04.2021

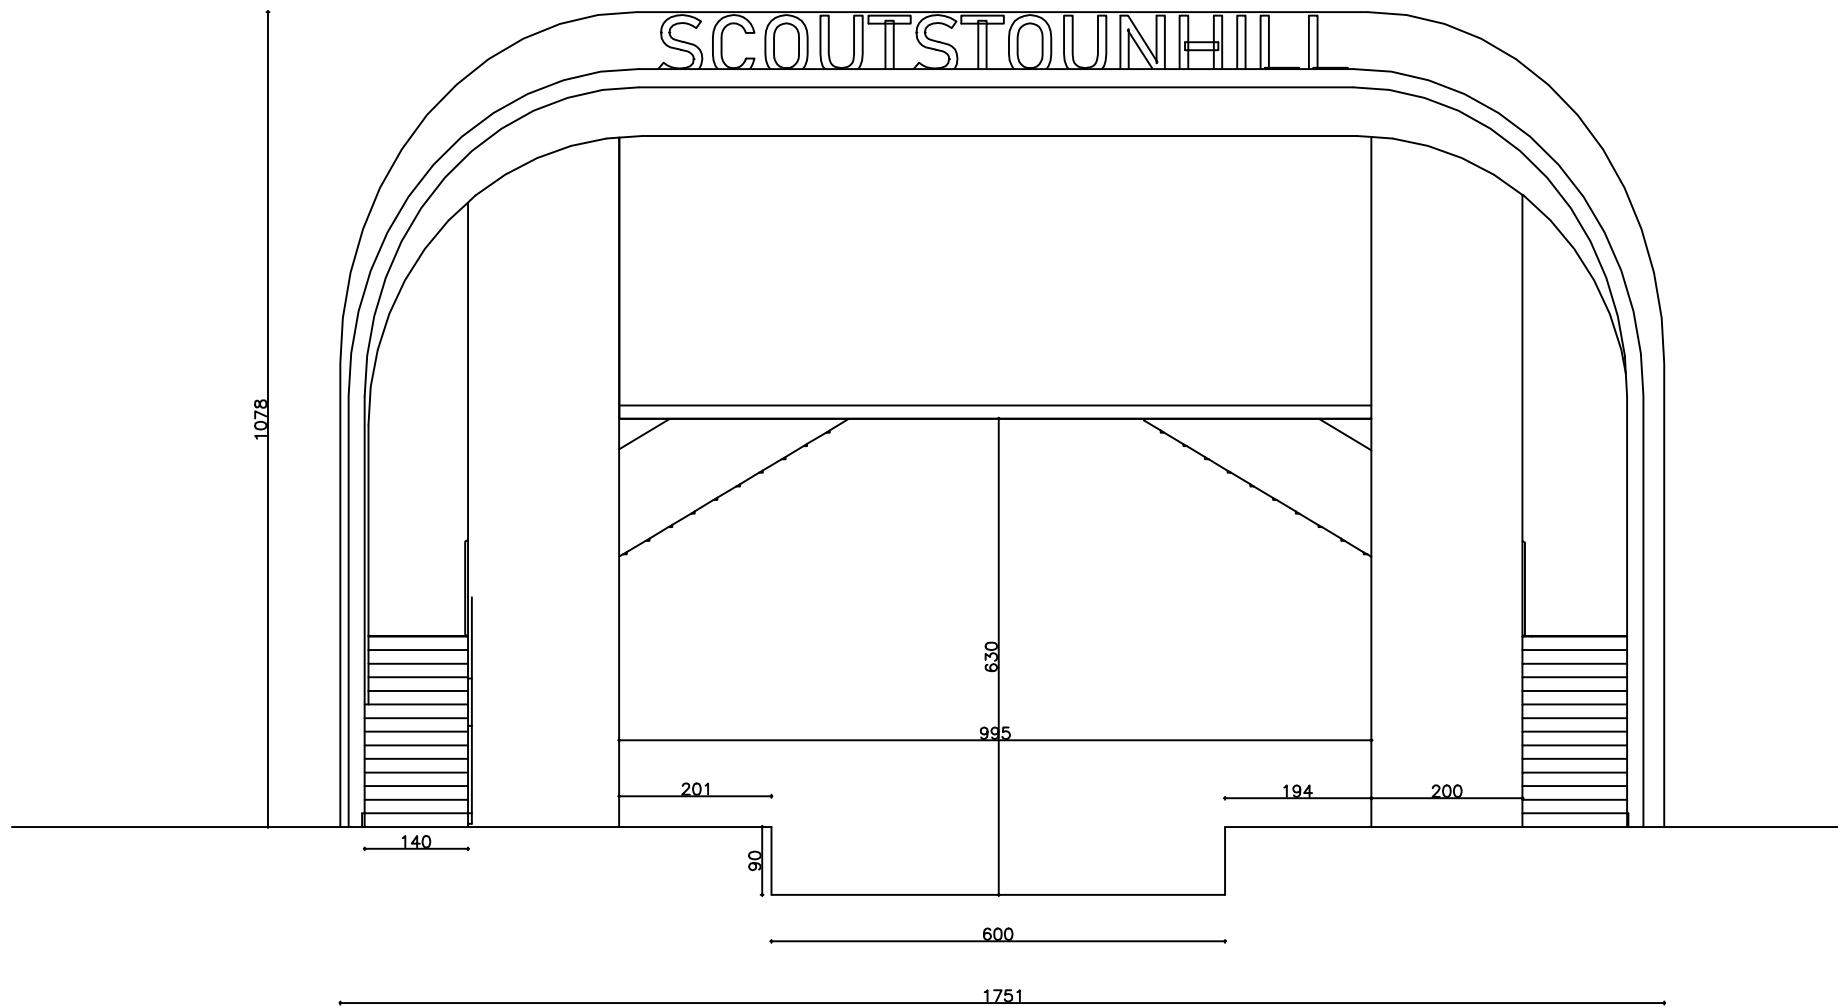

Project Name:

Scotstounhill Railway Station


Drawing Name:

Bridge Elevation


Scale 1:100 @A4

Sheet Number: 13/16

Date: 05.04.2021

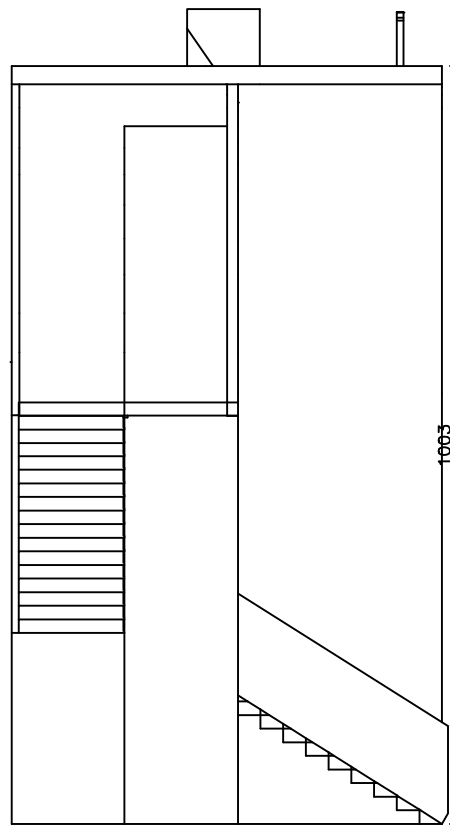

149 150

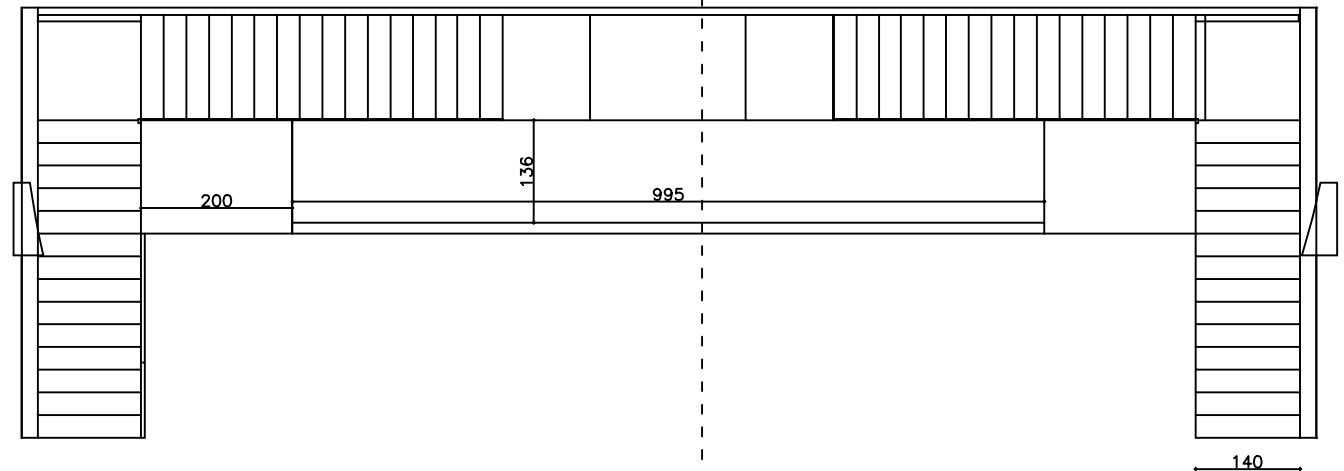

Project Name:

Scotstounhill Railway Station


Drawing Name:

Bridge Top View&Section

Scale 1:100 @A4

Sheet Number: 14/16

Date: 05.04.2021

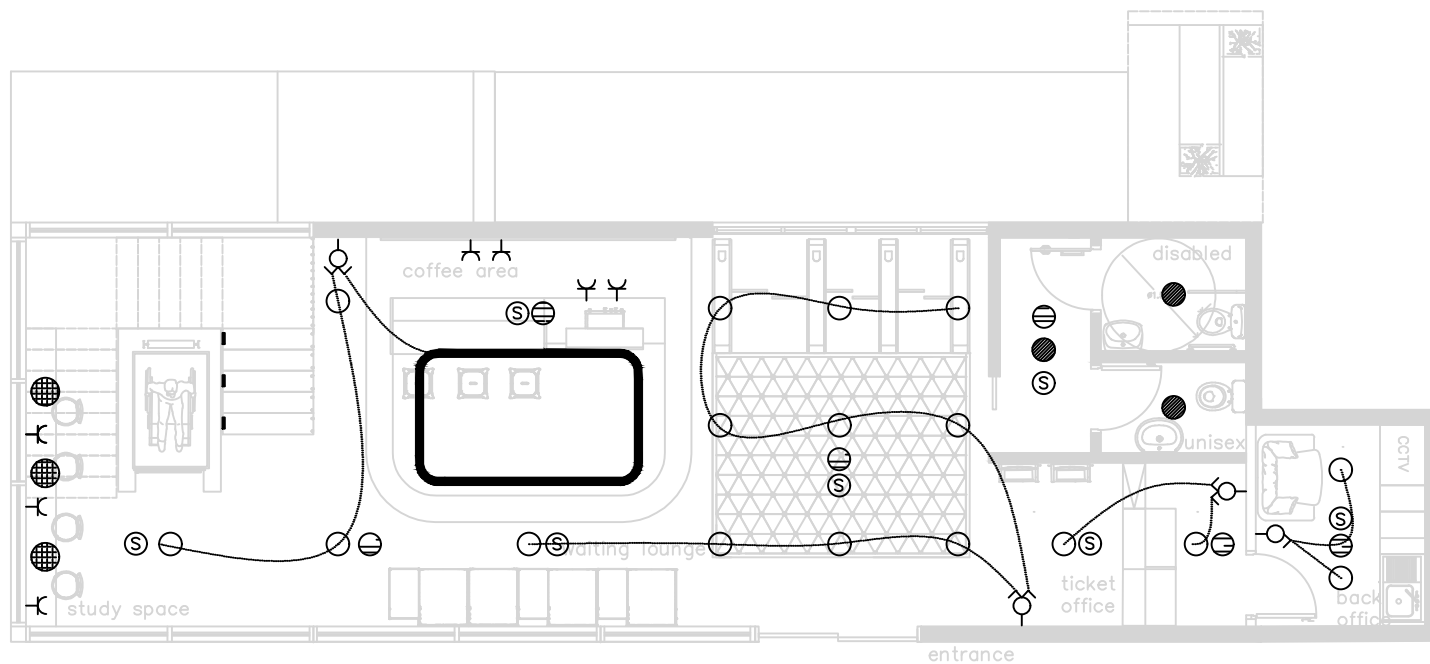

LEGEND	
	SINGLE SWITCH
	DOUBLE SWITCH
	SPRINKLER
	SMOKE DETECTOR
	SOCKET
	Surface Mounted Led Light (sensor)
	Surface Mounted Led Light (30cm)
	Stair Step Light
	Study Area Suspended Light



Project Name:

Scotstounhill Railway Station


Drawing Name:

Mechanic Plan Ground F

Scale 1:100 @A4

Sheet Number: 15/16

Date: 05.04.2021

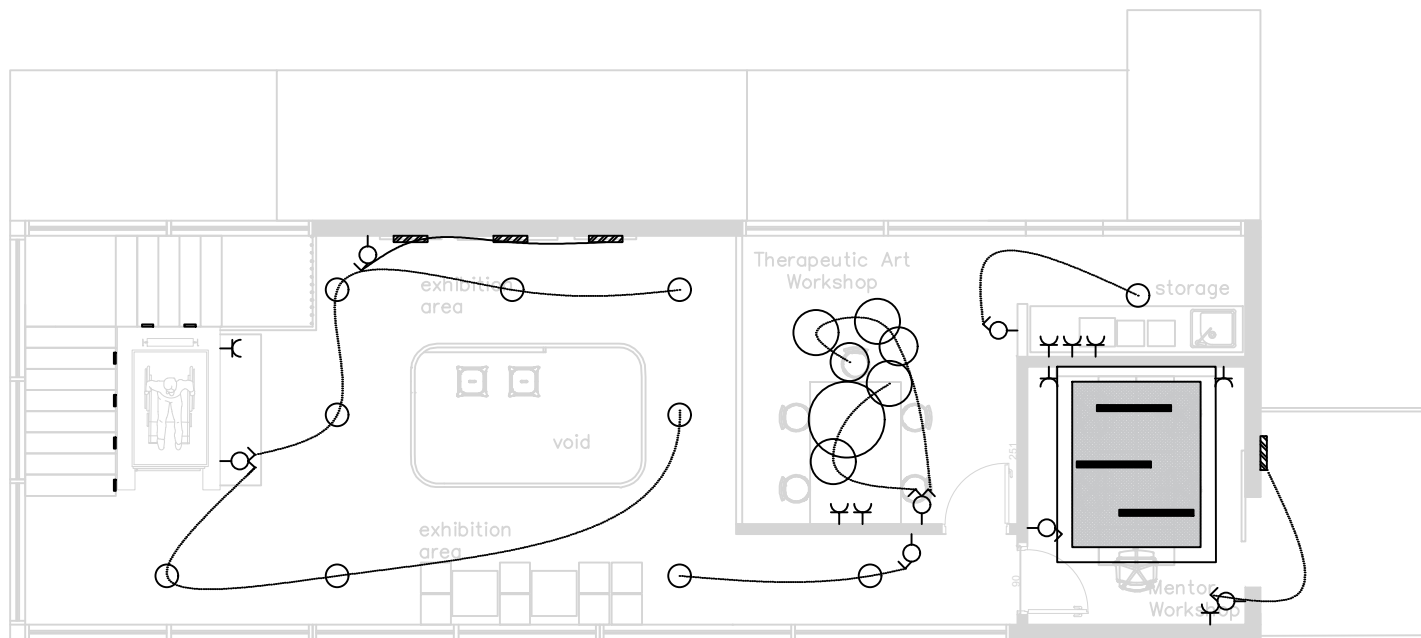

LEGEND	
	SINGLE SWITCH
	DOUBLE SWITCH
	SPRINKLER
	SMOKE DETECTOR
	SOCKET
	Surface Mounted Led Light (sensor)
	Surface Mounted Led Light (30cm)
	Stair Step Light
	Suspended Various Dimension Lights



Project Name:

Scotstounhill Railway Station

Drawing Name:

Mechanic Plan First F

Scale 1:100 @A4

Sheet Number: 16/16

Date: 05.04.2021